


EXISTING OLD JETTY

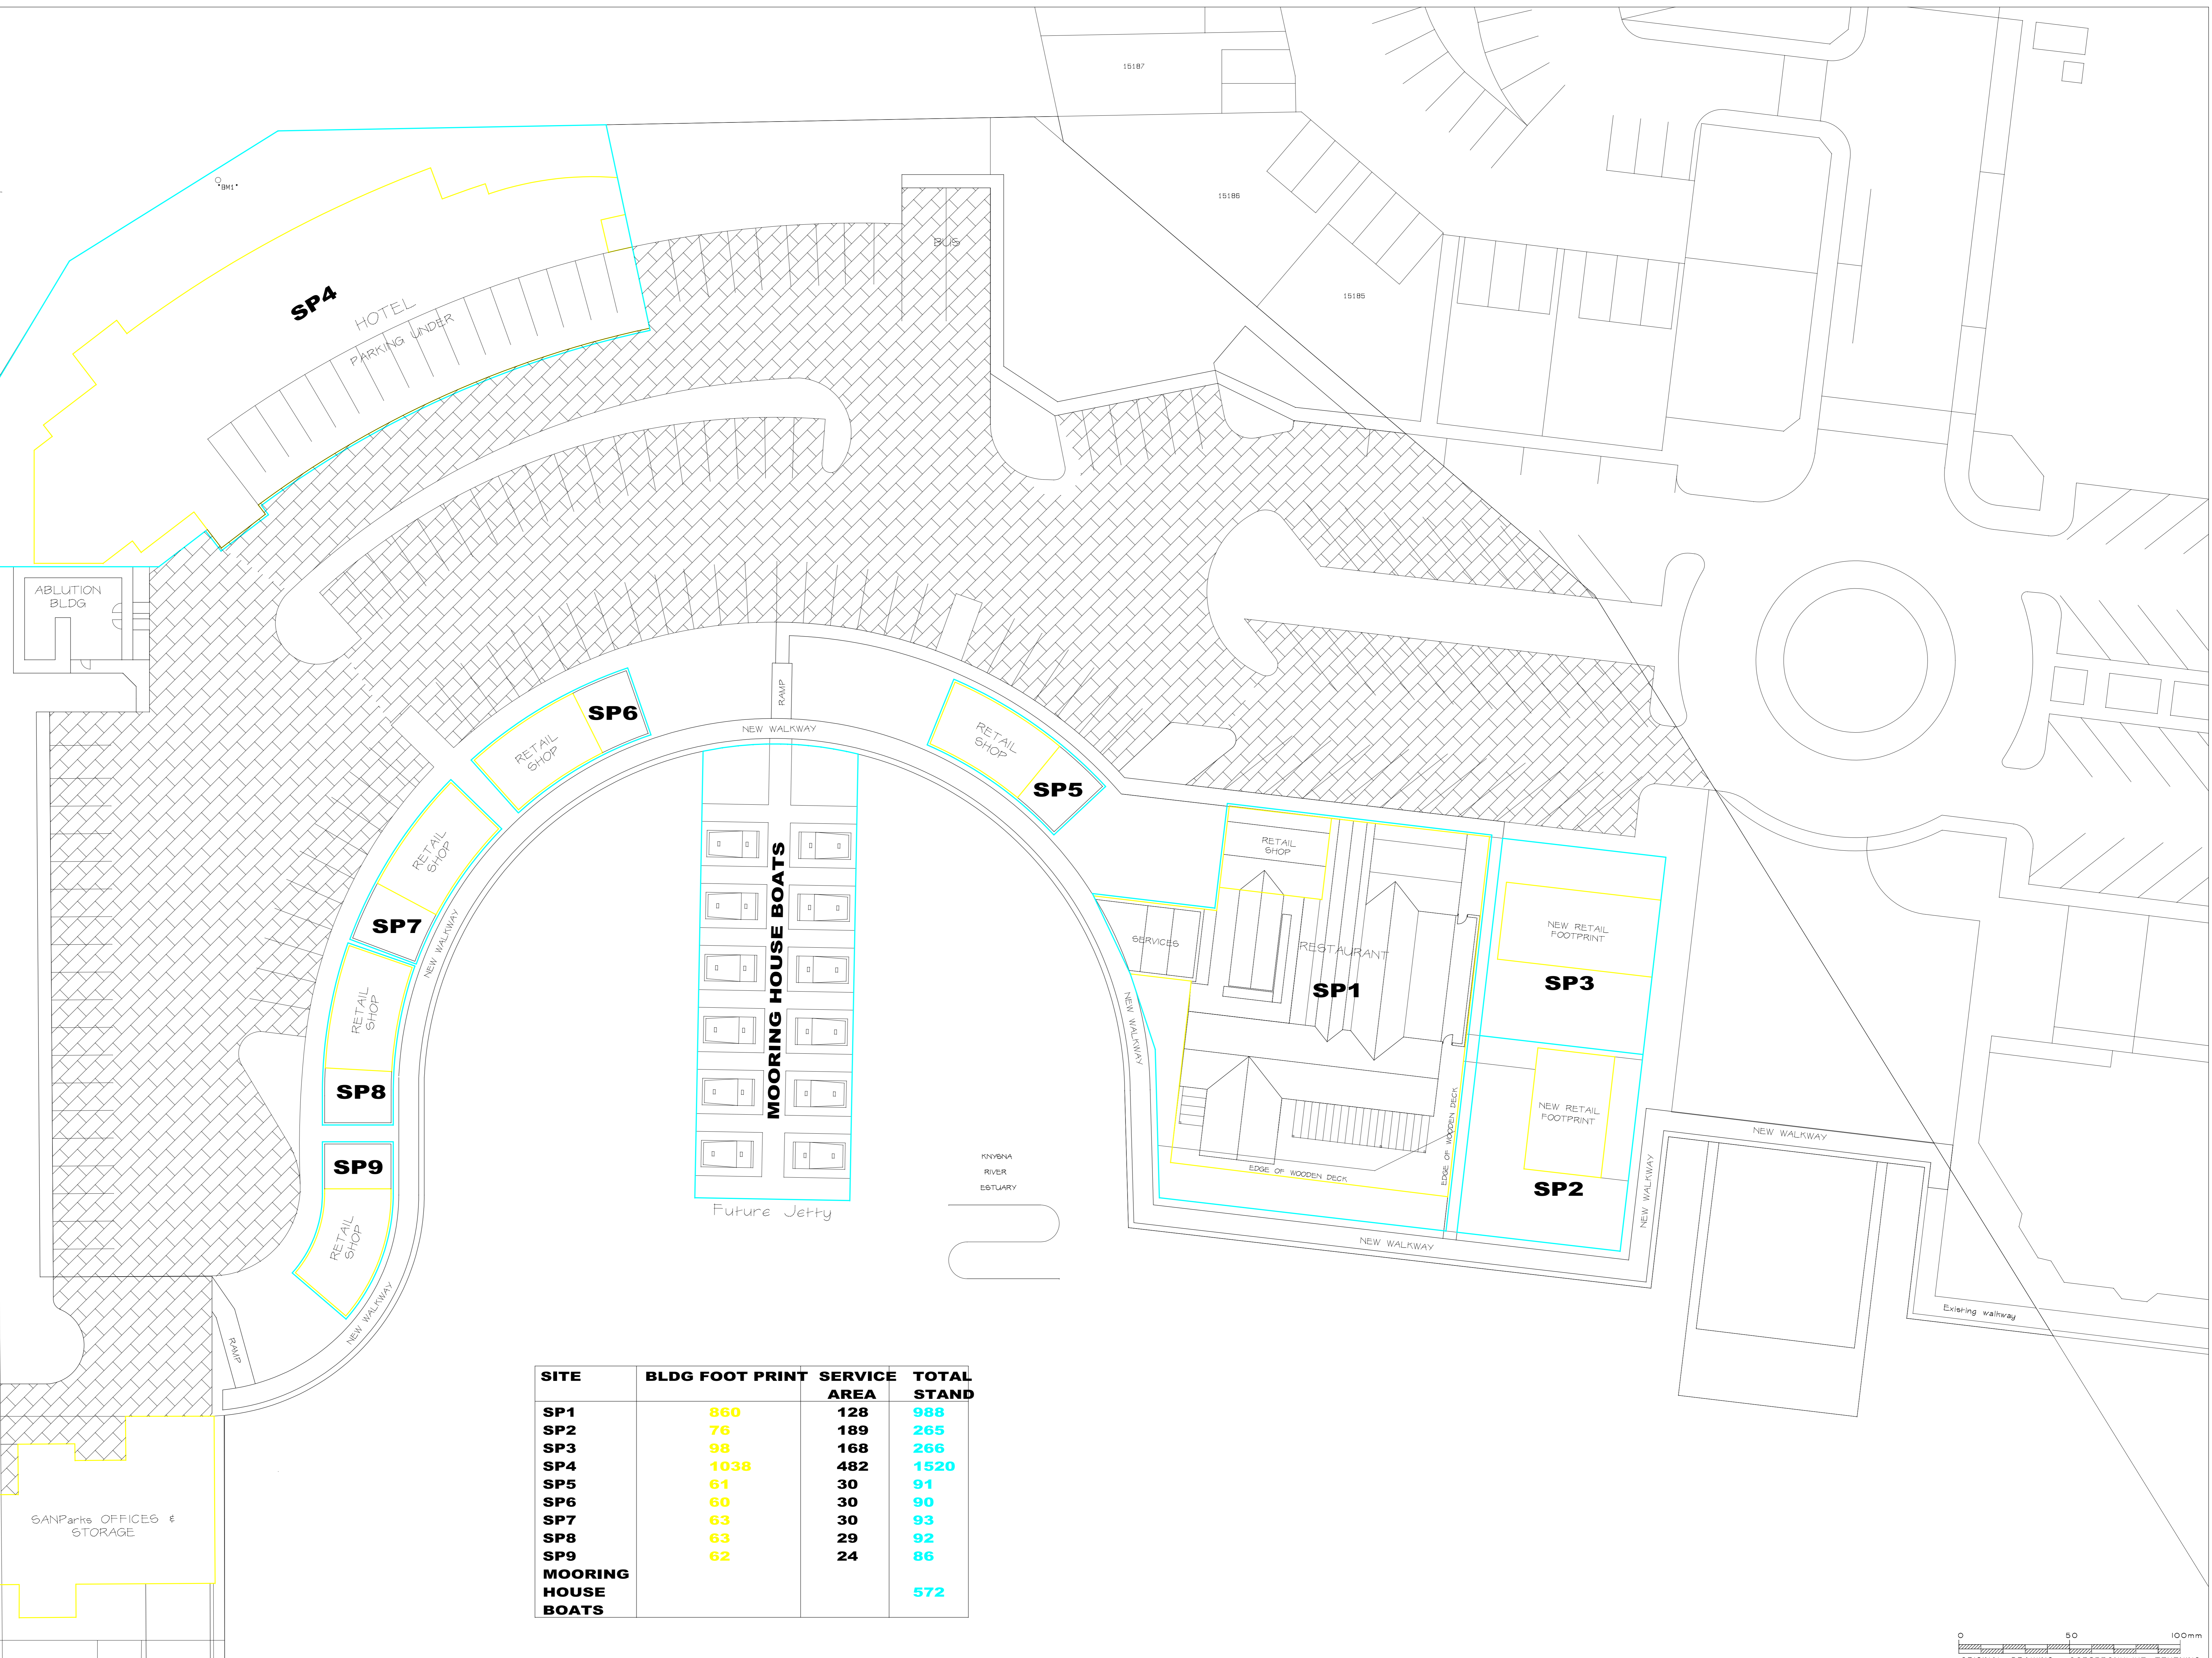

SITE	BLDG FOOT PRINT	SERVICE AREA	TOTAL STAND
SP1	860	128	988
SP2	76	189	265
SP3	98	168	266
SP4	1038	482	1520
SP5	61	30	91
SP6	60	30	90
SP7	63	30	93
SP8	63	29	92
SP9	62	24	86
MOORING HOUSE BOATS			572

SANParks OFFICES & STORAGE

Future Jetty

KNYSNA RIVER ESTUARY

0 50 100mm
ORIGINAL DRAWING OORSpronklike TEKENING

DRG. No.	REFERENCE DRAWINGS	REV	DESCRIPTION	DATE	CHKD	APPRV	REV	DESCRIPTION	DATE	CHKD	APPRV
	REFERENCE DRAWINGS		REVISIONS					REVISIONS			

DESIGNED	
DRAWN	
CHECKED	
PROJ. ENG.	
PROJ. MANAGER	
APPROVED :	

PO Box 1480
KNYSNA
6570

Tel: (044) 382-5293
Fax: (044) 382-6577
E-mail: ssi@knyssi.co.za

CLIENT:
SOUTH AFRICAN NATIONAL PARKS

PROJECT/DRAWING TITLE
SANParks THESEN ISLAND DEVELOPMENT
BUILDING FOOT PRINTS AND STANDS

SCALE NTS	SHT. No. 1 OF 1
CONTRACT No. CI-KM-0001	PROJECT No. W00.GRJ.000059
DRAWING No. W.GRJ.000059/C/200CA	REV