



ELECTRICAL SCHEDULE	
	220/230 VOLT POWER POINTS
	400/231 VOLT 3 PHASE POWER POINTS
	DOUBLE 80 WATT FLOURESCENT LIGHTS
	SINGLE INCANDESCENT LIGHT FITTINGS
	AIR CONDITIONING UNITS
	DB BOARD

ENGINEERS OFFICE
SCALE 1:25

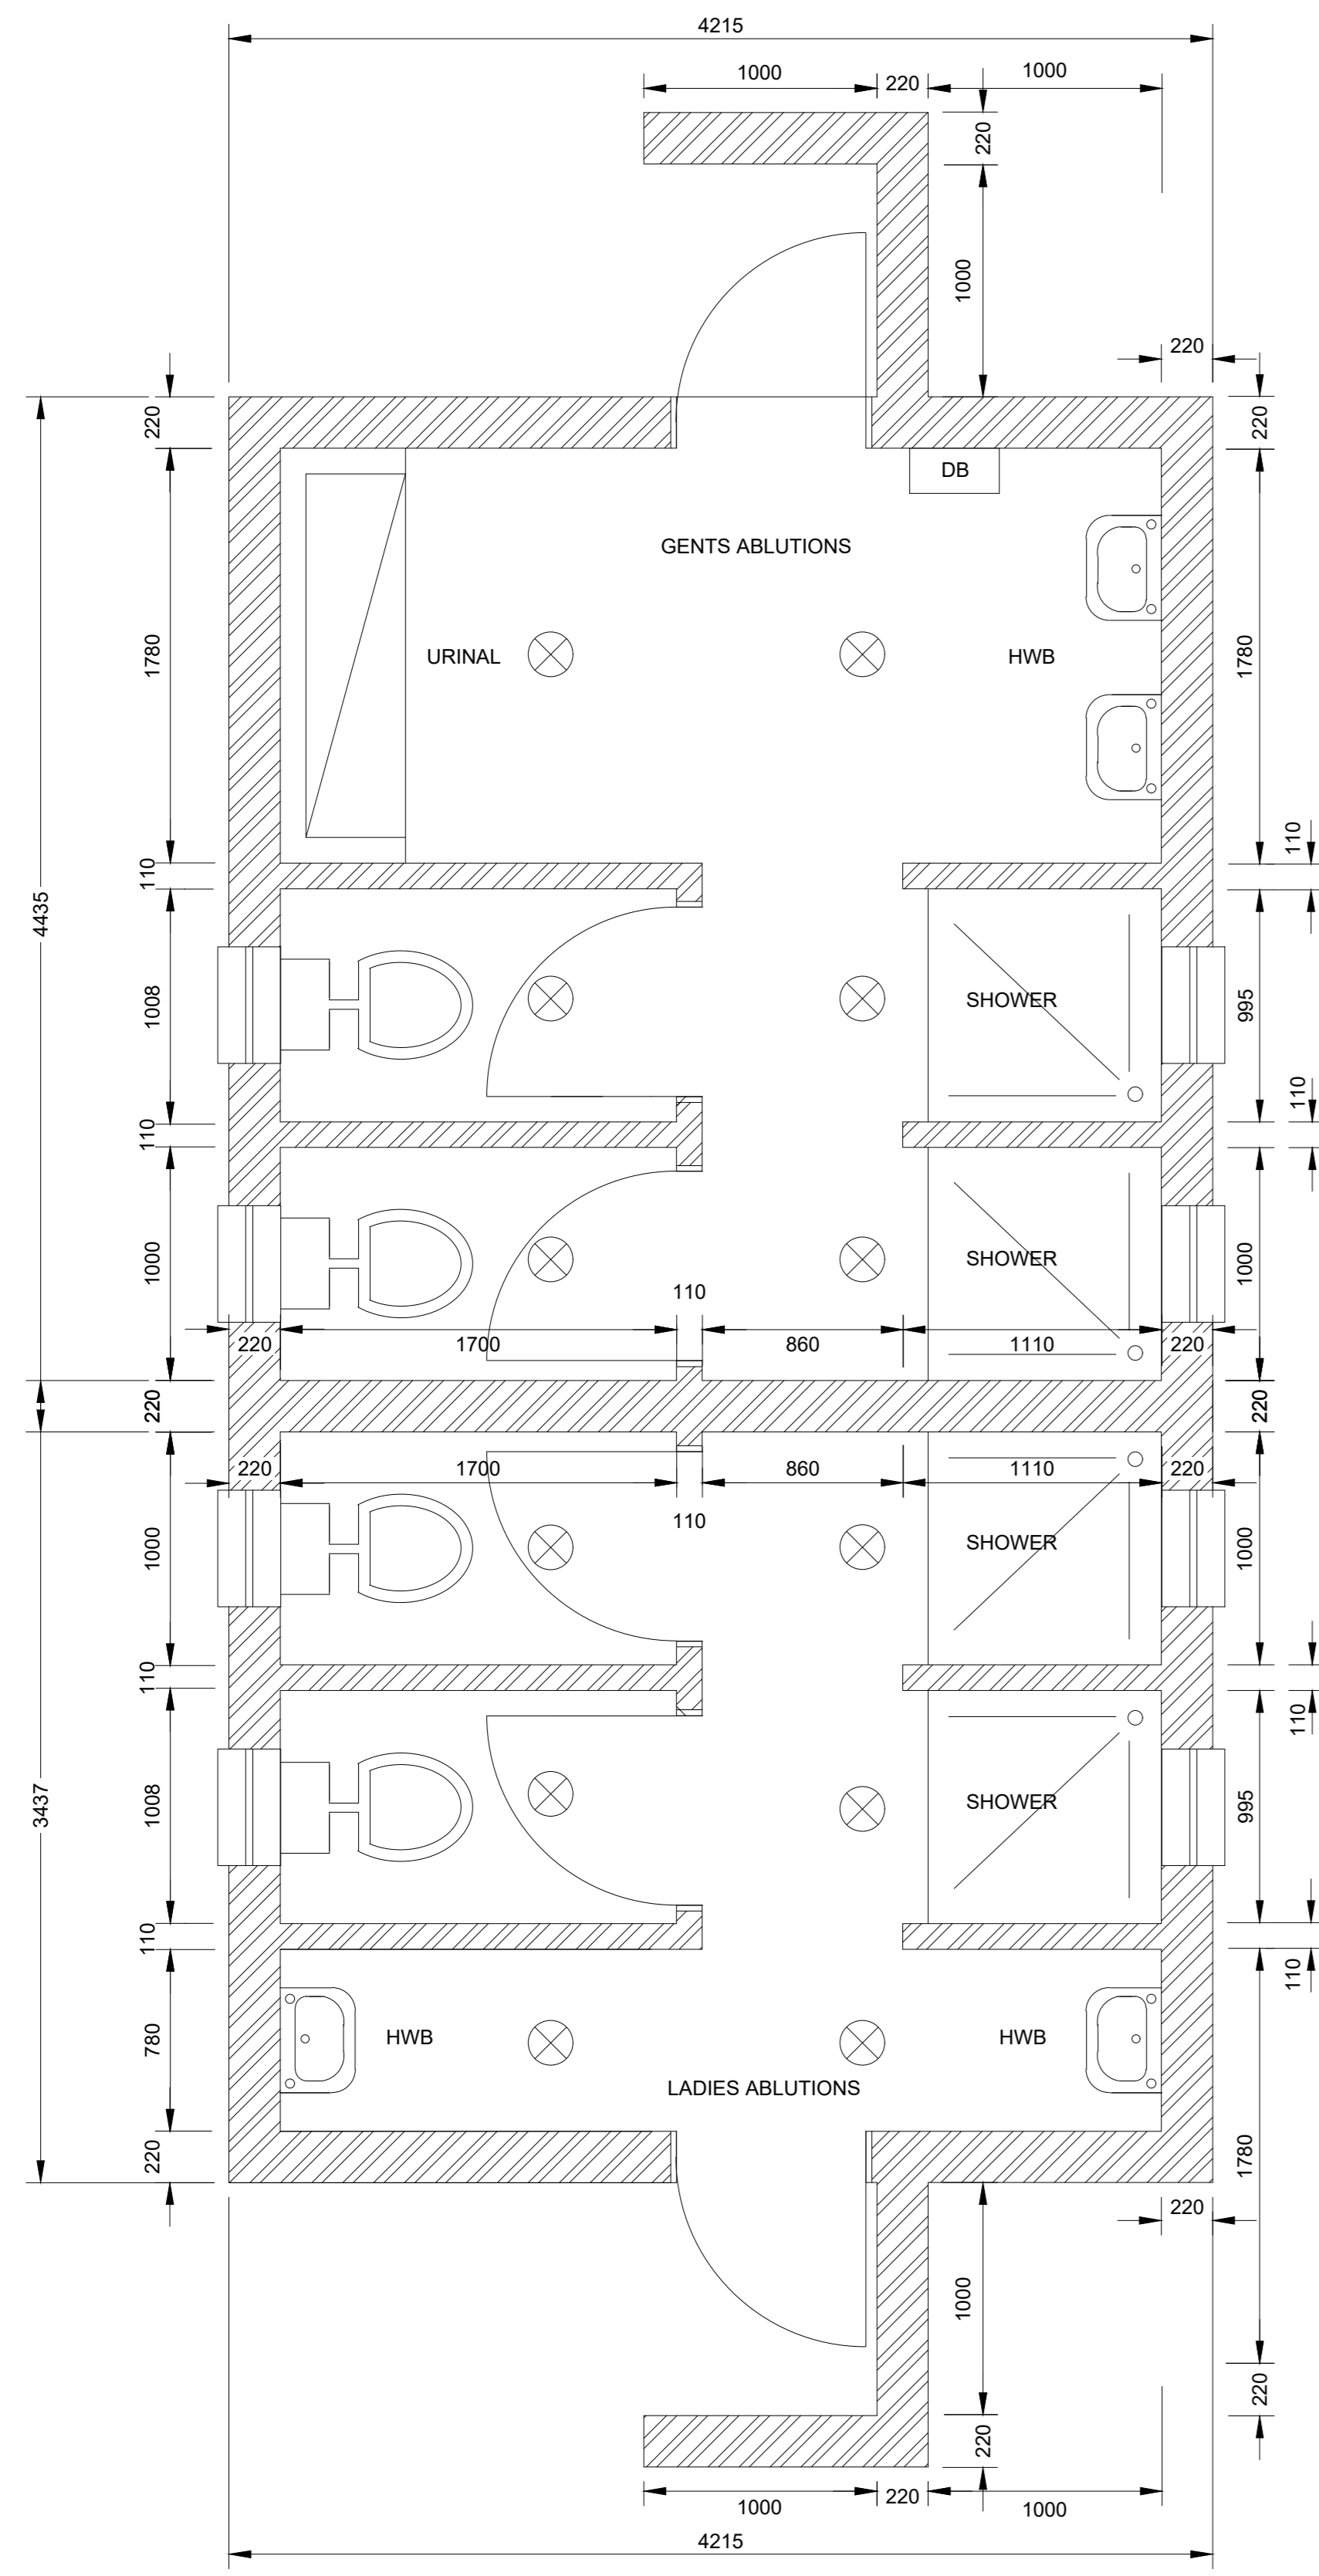

ABLUTION BLOCK
SCALE 1:25

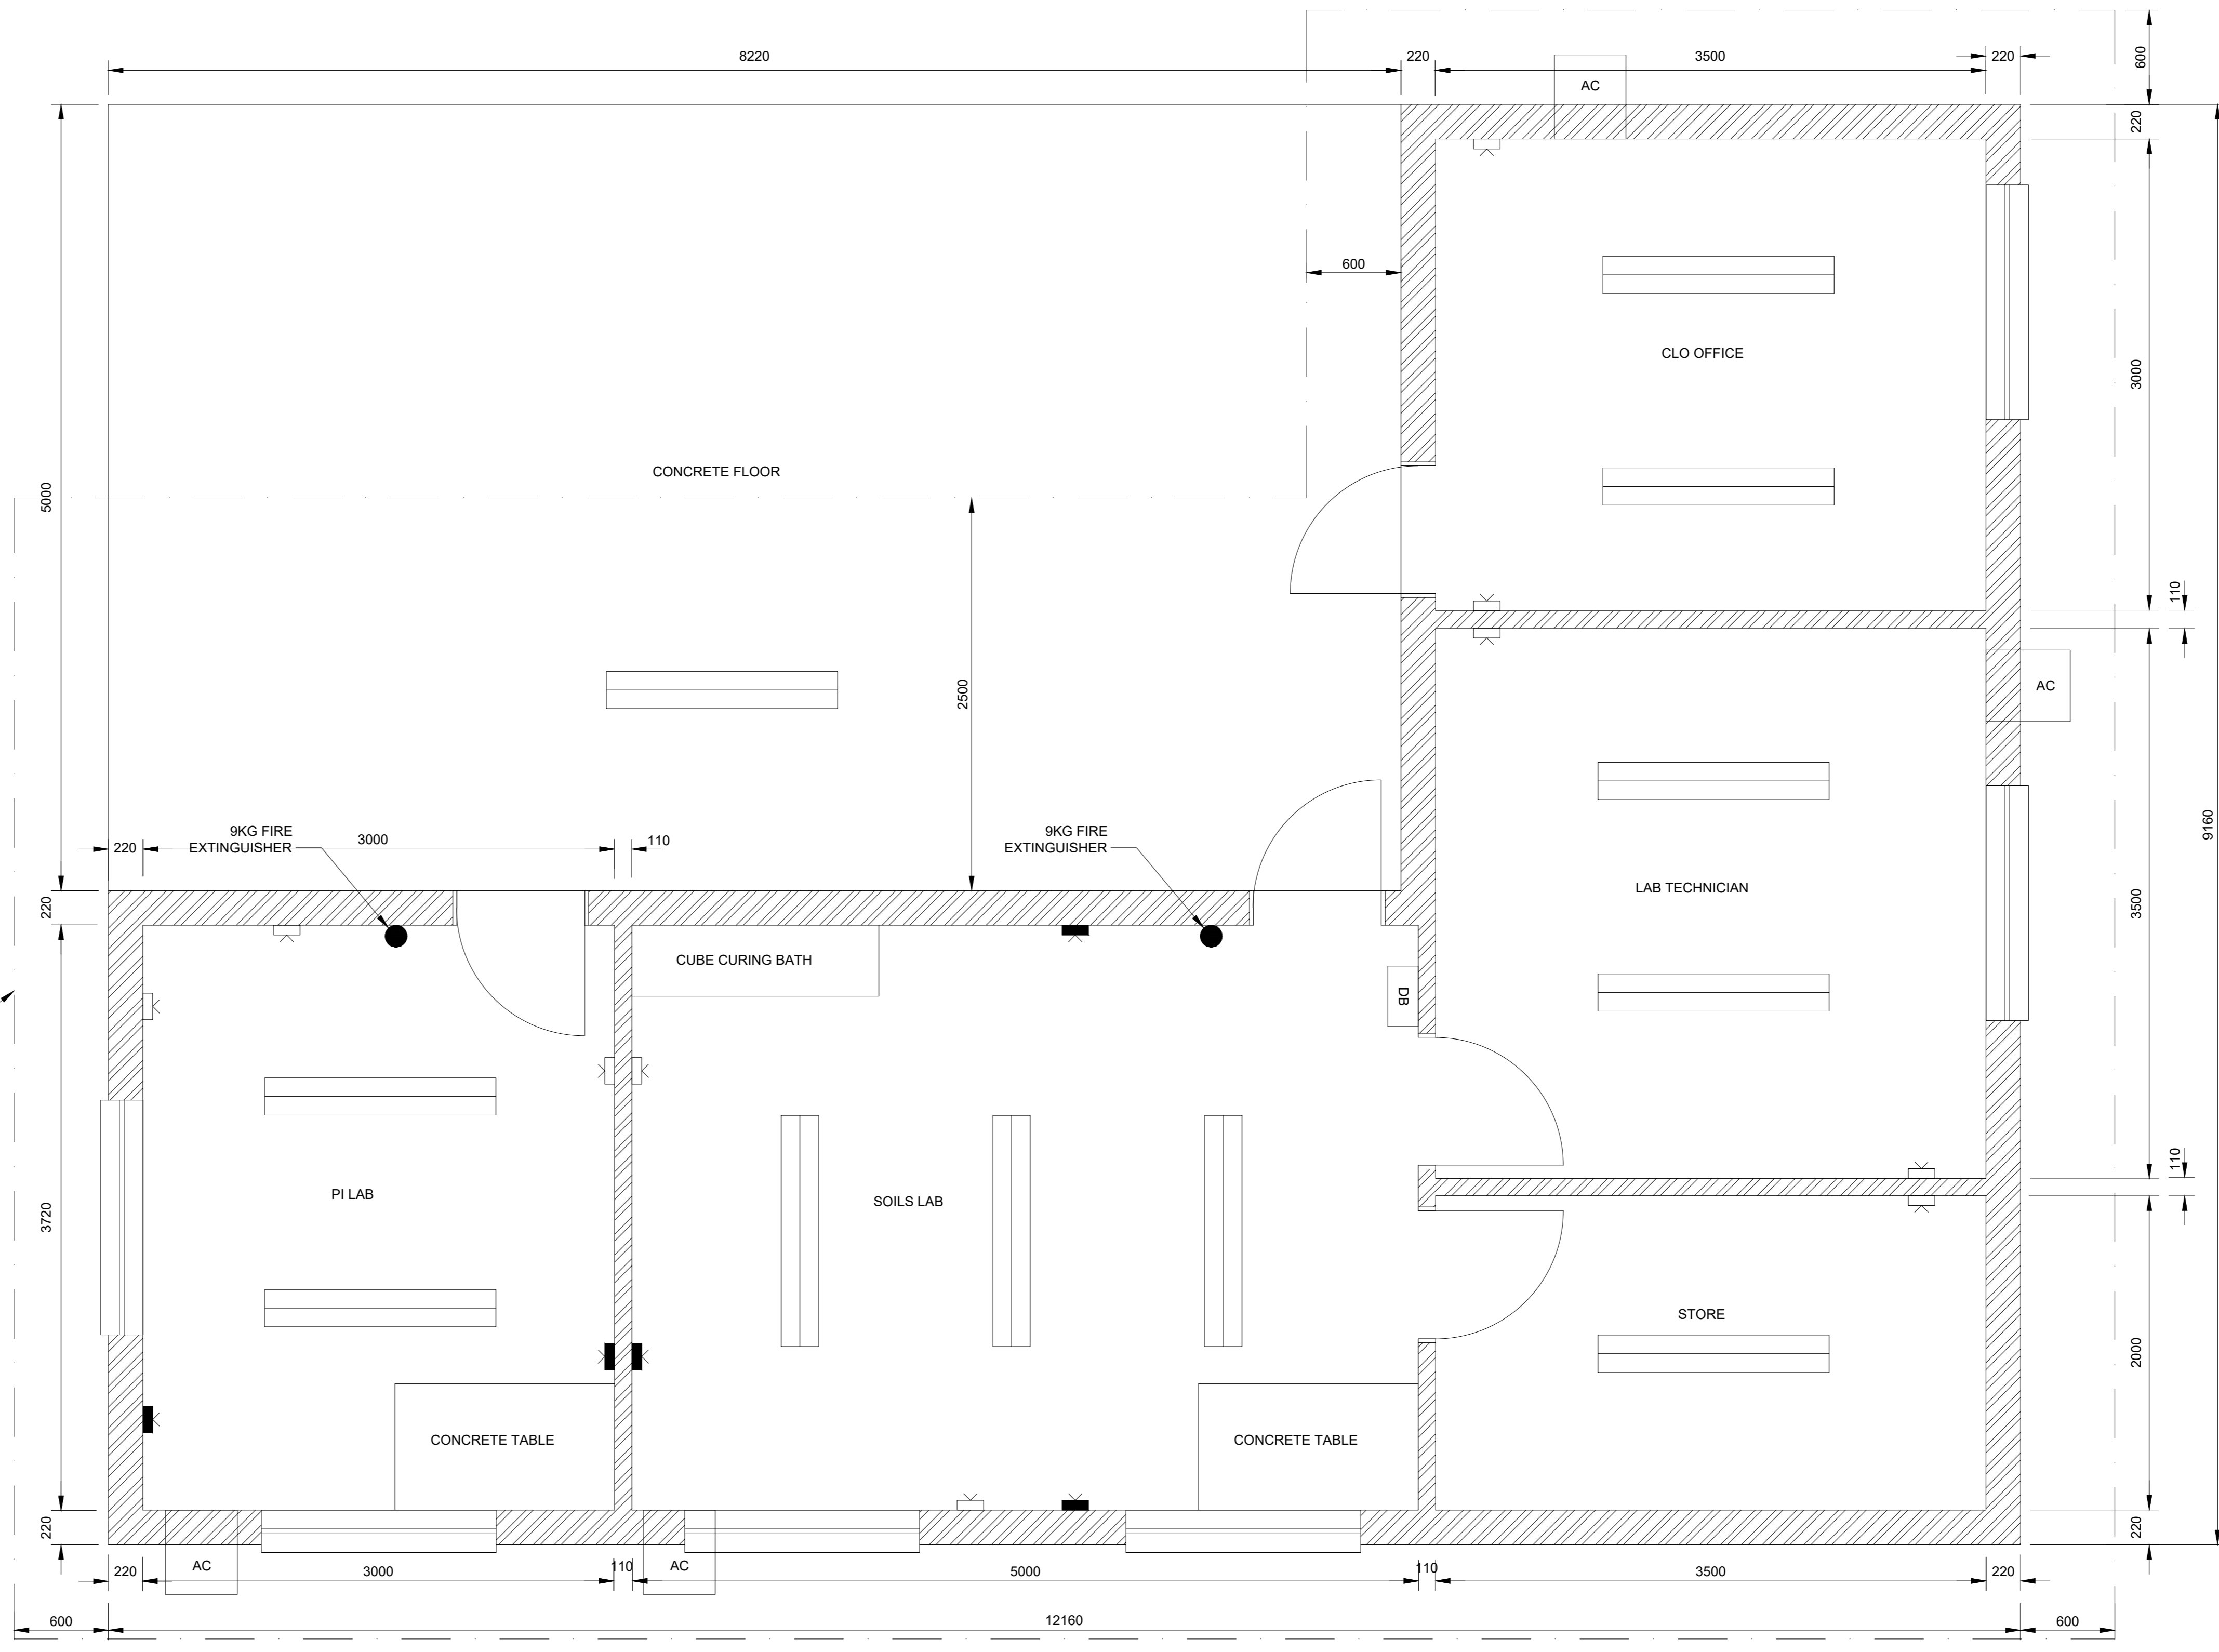

LABORATORY BLOCK
SCALE 1:25

TECHNICAL SERVICES DEPARTMENT KRUGER NATIONAL PARK DRAWING OFFICE (KNP) Tel: (013) 735 3448		DESIGNED BY: AJ. NEL CHECKED BY: J.L. VENTER DRAWN BY: R. HATTINGH CHECKED BY: C.F. SMIT	APPROVED BY: <table border="1"> <tr> <td>SEN. MAN. CIVIL & BUILDING</td> <td>SEN. MAN. ELECTRO & MECHANICAL</td> <td>SEN. MAN. ROADS & MAINTENANCE</td> <td>MAN. PLANNING & DESIGN</td> <td>CLIENT</td> </tr> <tr> <td>DATE:</td> <td>DATE:</td> <td>DATE:</td> <td>DATE:</td> <td>DATE:</td> </tr> </table>	SEN. MAN. CIVIL & BUILDING	SEN. MAN. ELECTRO & MECHANICAL	SEN. MAN. ROADS & MAINTENANCE	MAN. PLANNING & DESIGN	CLIENT	DATE:	DATE:	DATE:	DATE:	DATE:	SERVICE: ROADS FOR TENDER PURPOSES	PROJECT: SHANGONI ROAD PHASE 1	TITLE: STRUCTURAL: ELECTRICAL LAYOUT OF ENGINEERING OFFICE, LABORATORY BUILDING & ABLUTION BLOCK	DATE: MAY 2024 SCALE: 1:25	CAD FILE NAME: 2019/P09 PAPER SIZE: A0	CONSULTANT DWG. NO.: EN/3587/G/2/001 CLIENT DWG. NO.:
SEN. MAN. CIVIL & BUILDING	SEN. MAN. ELECTRO & MECHANICAL	SEN. MAN. ROADS & MAINTENANCE	MAN. PLANNING & DESIGN	CLIENT															
DATE:	DATE:	DATE:	DATE:	DATE:															

(REF FOLDER: X:102 PROJECTS\3000\3500 - 3599\N3587EN - SHANGONI ROAD KNP\1 DESIGN PHASE\DRAWINGS\TENDER\ROADS\EN3587G2001-2.DWG)

