

ALL LOCAL & NATIONAL BUILDING REGULATIONS MUST BE COMPLIED WITH. ALL DIMENSIONS TO BE CHECKED ON SITE.
 THIS DRAWING TO BE USED ONLY ON ORIGINAL DESIGNATED SITE UNLESS OTHERWISE AGREED BY ARCHITECTS.
 Copyright Reserved Crafford & Crafford Architects © 2002


Drawing Title **QWA QWA REST CAMP - SITEPLAN**

Tekening Naam 1796.0
 Drawn PN Geteken Project 0220-E Projek TEK # DWG 101
 Scale 1 : 1000 Skaal Date 22.09.2003 Datum

REVISION WYSIGING


CAMP ACCOMODATION:
 35 UNITS in 17 KRAALS
 6 x 1 UNIT KRAALS
 4 x 2 UNIT KRAALS
 7 x 3 UNIT KRAALS
 = 70 BEDS + 34 BUNKBEDS
 = 104 BEDS TOTAL

PROVISIONAL VOORLOPIG

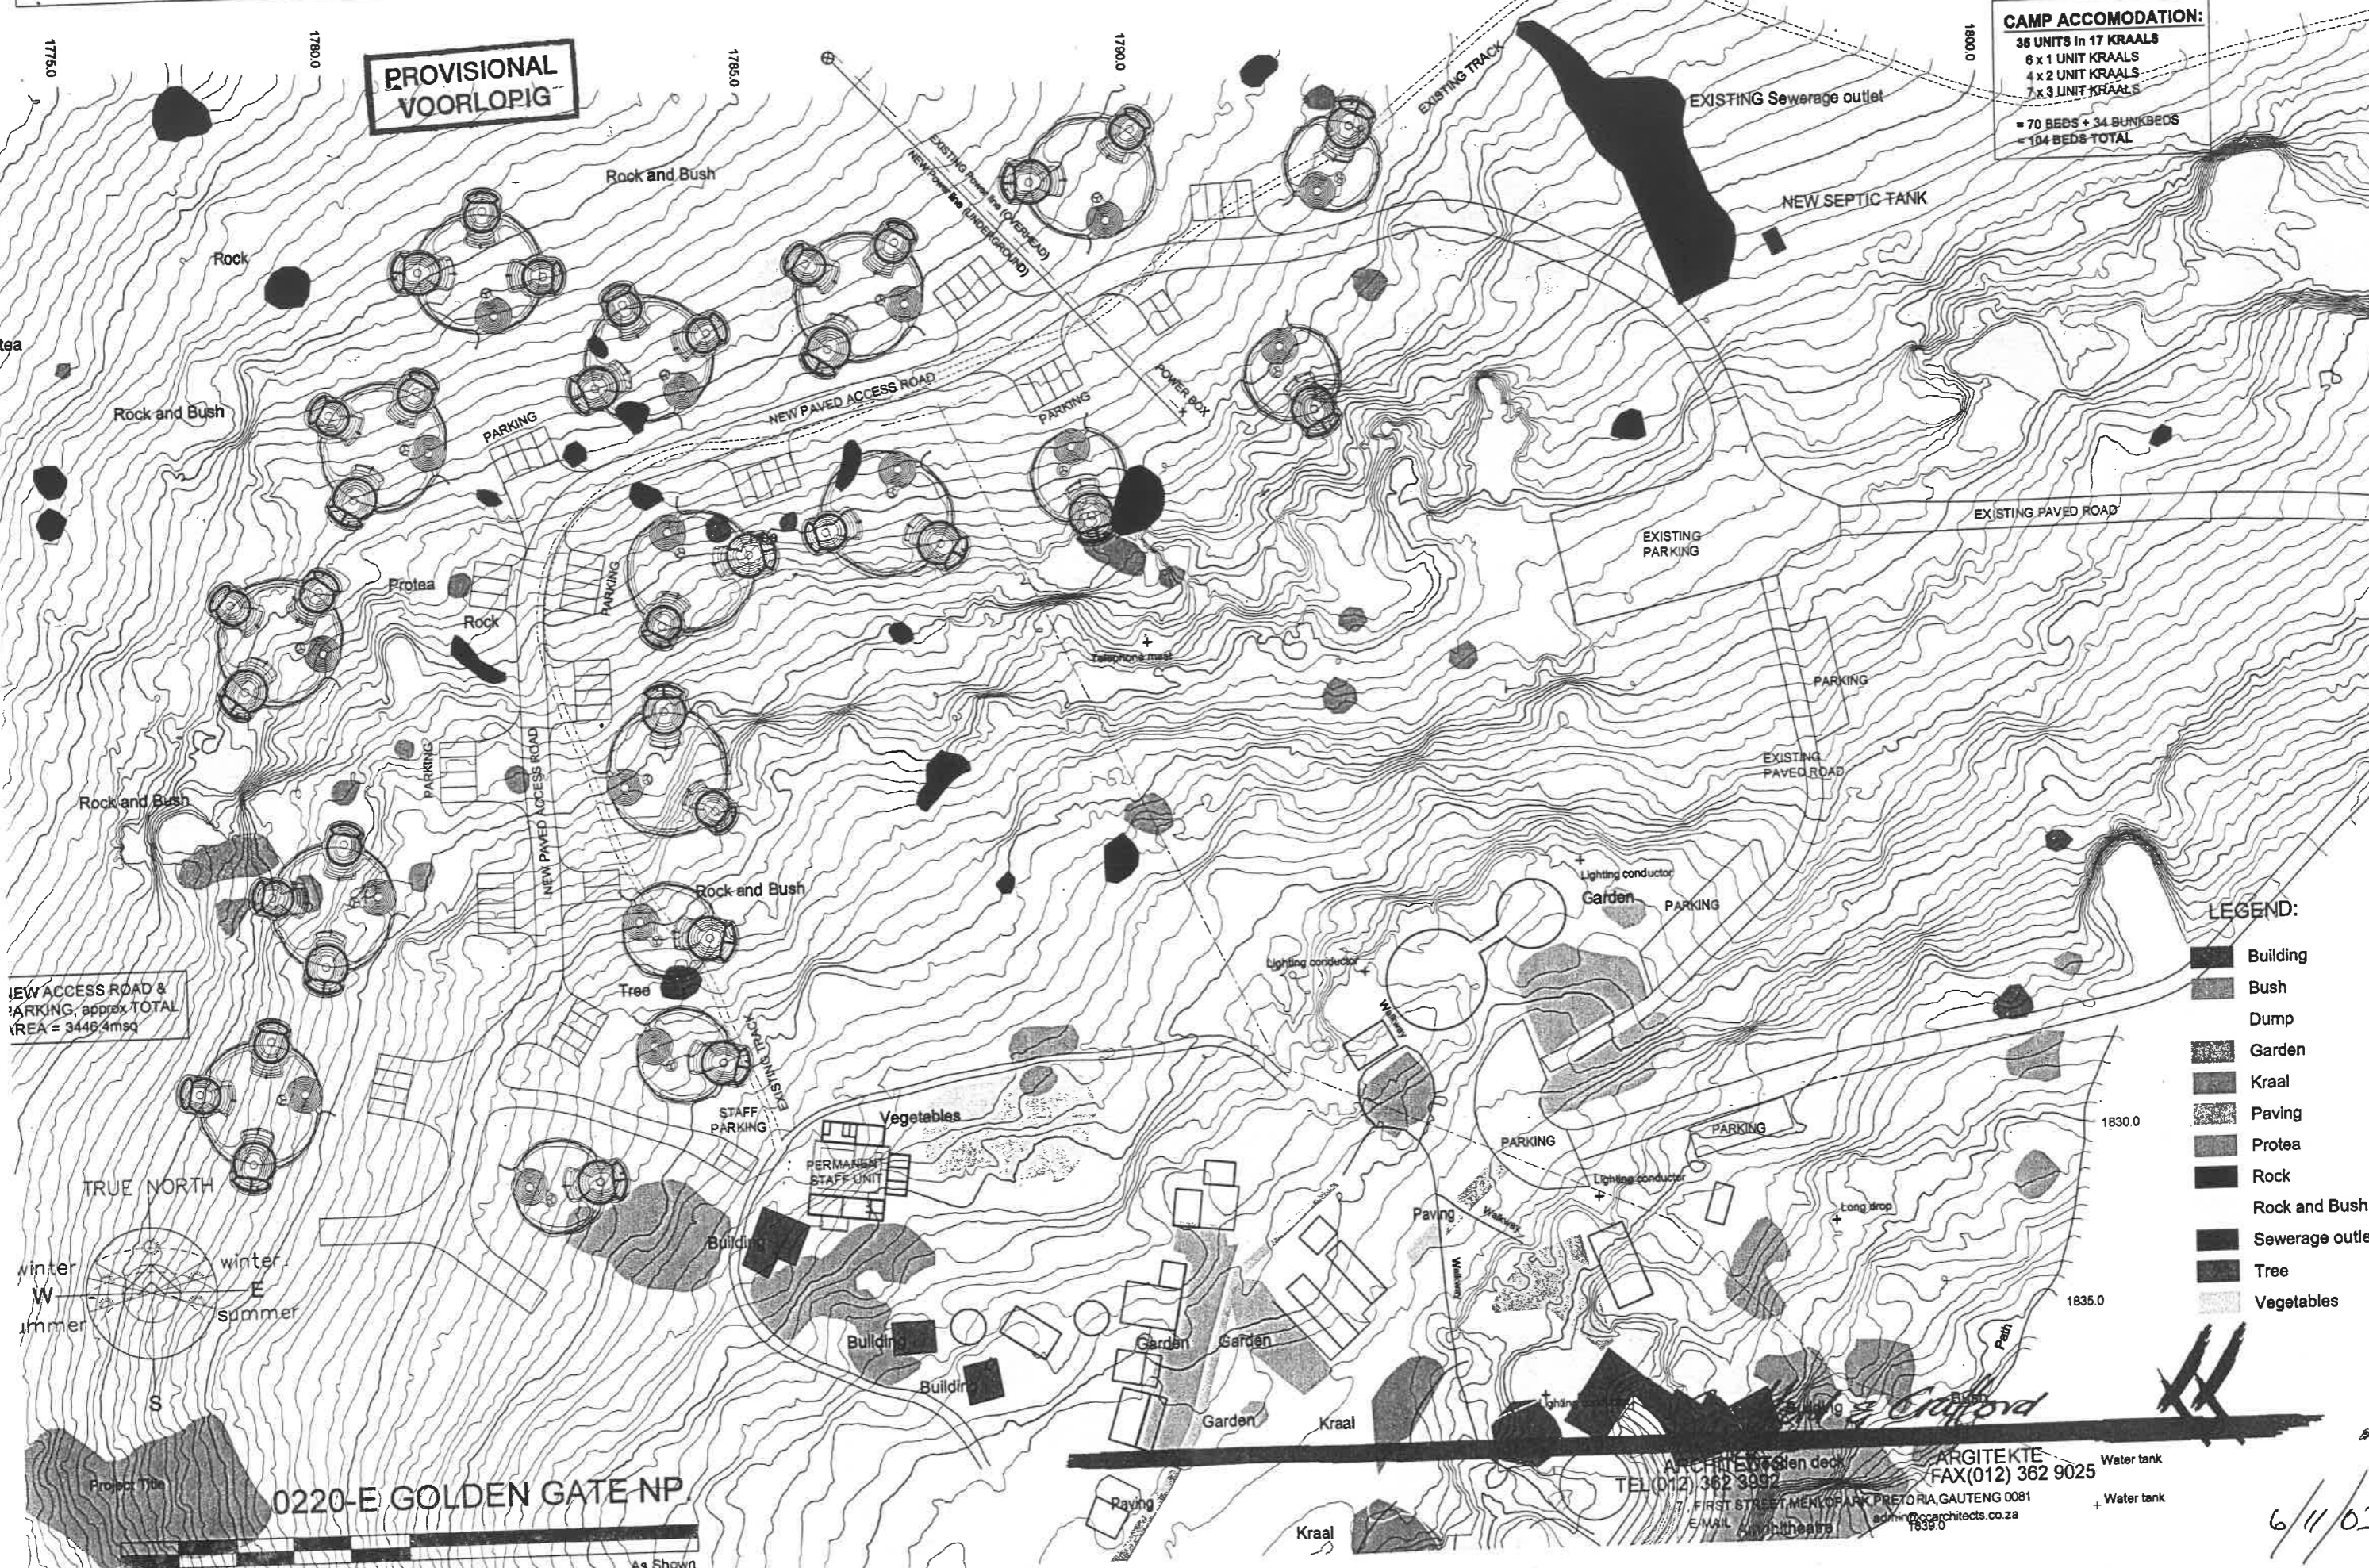

- LEGEND:**
- Building
 - Bush
 - Dump
 - Garden
 - Kraal
 - Paving
 - Protea
 - Rock
 - Rock and Bush
 - Sewerage outlet
 - Tree
 - Vegetables

NEW ACCESS ROAD & PARKING, approx TOTAL AREA = 3446,4msq

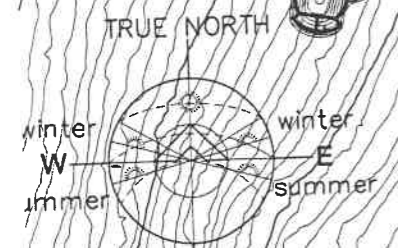

0220-E GOLDEN GATE NP
 Scale As Shown

ARCHITECTS Crafford & Crafford
 TEL (012) 362 3992
 7, FIRST STREET, MENLO PARK, PRETORIA, GAUTENG 0081
 E-MAIL: admin@crafford.co.za
 ARGITEKTE
 FAX (012) 362 9025
 Water tank
 + Water tank

6/11/03

ALL LOCAL & NATIONAL BUILDING REGULATIONS MUST BE COMPLIED WITH. ALL DIMENSIONS TO BE CHECKED ON SITE
 THIS DRAWING TO BE USED ONLY ON ORIGINAL DESIGNATED SITE UNLESS OTHERWISE AGREED BY ARCHITECTS
 Copyright Reserved Crafford & Crafford Architects © 2002

Drawing Title

Water Reticulation
QWAQWA SITE: ELECTRICAL LAYOUT

Tekening Naam 796.0

Drawn PN
 Scale 1 : 1000


Geteken Project 0220-E
 Skaal Date 20.10.2003

Projek TEK # DWG
 Datum 102


**PROVISIONAL
 VOORLOPIG**

CAMP ACCOMODATION:
 35 UNITS in 17 KRAALS
 6 x 1 UNIT KRAALS
 4 x 2 UNIT KRAALS
 7 x 3 UNIT KRAALS
 = 70 BEDS + 34 BUNKBEDS
 = 104 BEDS TOTAL

REVISION WYSIGING

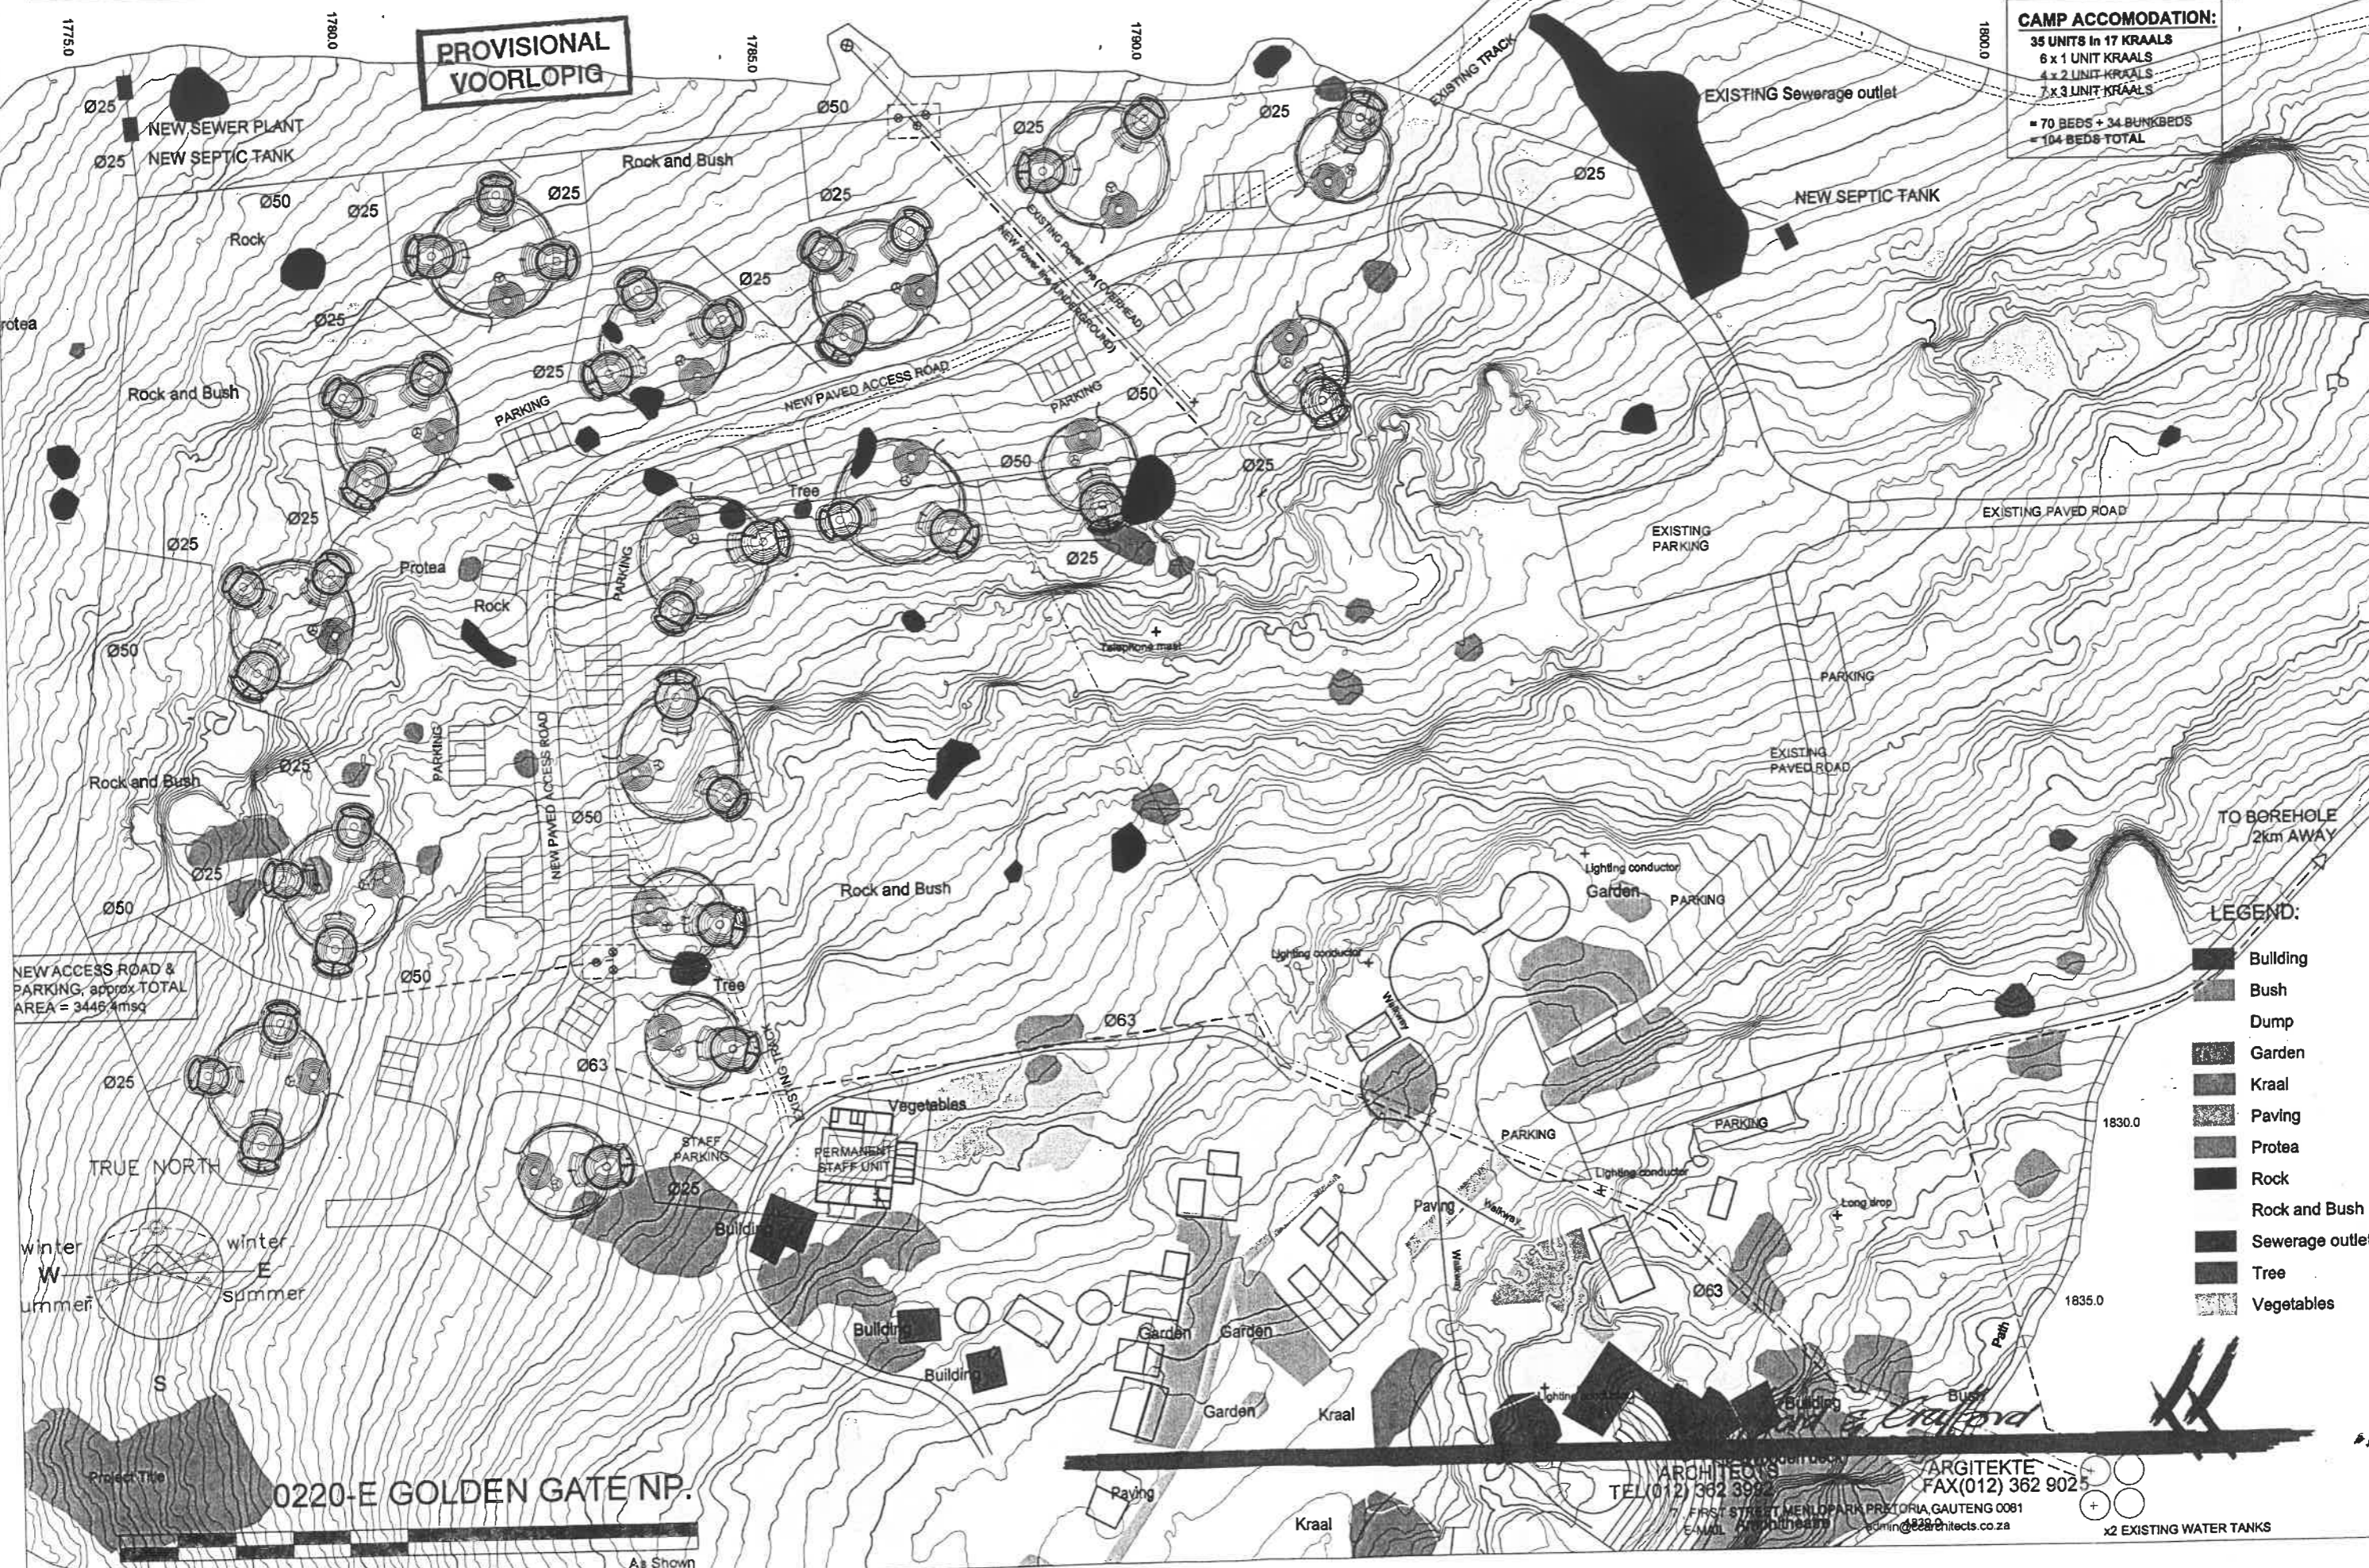

NEW ACCESS ROAD & PARKING, approx TOTAL AREA = 3445 m²

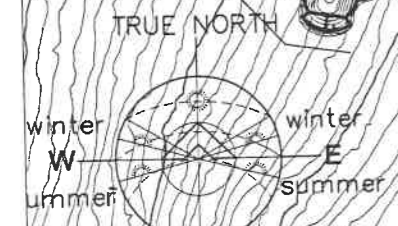

- LEGEND:**
- Building
 - Bush
 - Dump
 - Garden
 - Kraal
 - Paving
 - Protea
 - Rock
 - Rock and Bush
 - Sewerage outlet
 - Tree
 - Vegetables

Project Title **0220-E GOLDEN GATE NP.**

ARCHITECTS
 TEL (012) 362 3997
 FIRST STREET, MENLO PARK, PRETORIA, GAUTENG 0081
 EMAIL: info@architects.co.za

ARGITEKTE
 FAX (012) 362 9025

2 X EXISTING WATER TANKS

ALL LOCAL & NATIONAL BUILDING REGULATIONS MUST BE COMPLIED WITH. ALL DIMENSIONS TO BE CHECKED ON SITE.
THIS DRAWING TO BE USED ONLY ON ORIGINAL DESIGNATED SITE UNLESS OTHERWISE AGREED BY ARCHITECTS.
Copyright Reserved Crafford & Crafford Architects © 2002


Drawing Title **QWAQWA SITE: ELECTRICAL LAYOUT**

Tekening Naam 796.0

Drawn PN Geteken Project 0220-E Projek TEK # DWG 102 103
Scale 1:1000 Skaal Date 20.10.2003 Datum

CAMP ACCOMODATION:
35 UNITS in 17 KRAALS
8 x 1 UNIT KRAALS
4 x 2 UNIT KRAALS
7 x 3 UNIT KRAALS
= 70 BEDS + 34 BUNKBEDS
= 104 BEDS TOTAL

REVISION WYSIGING

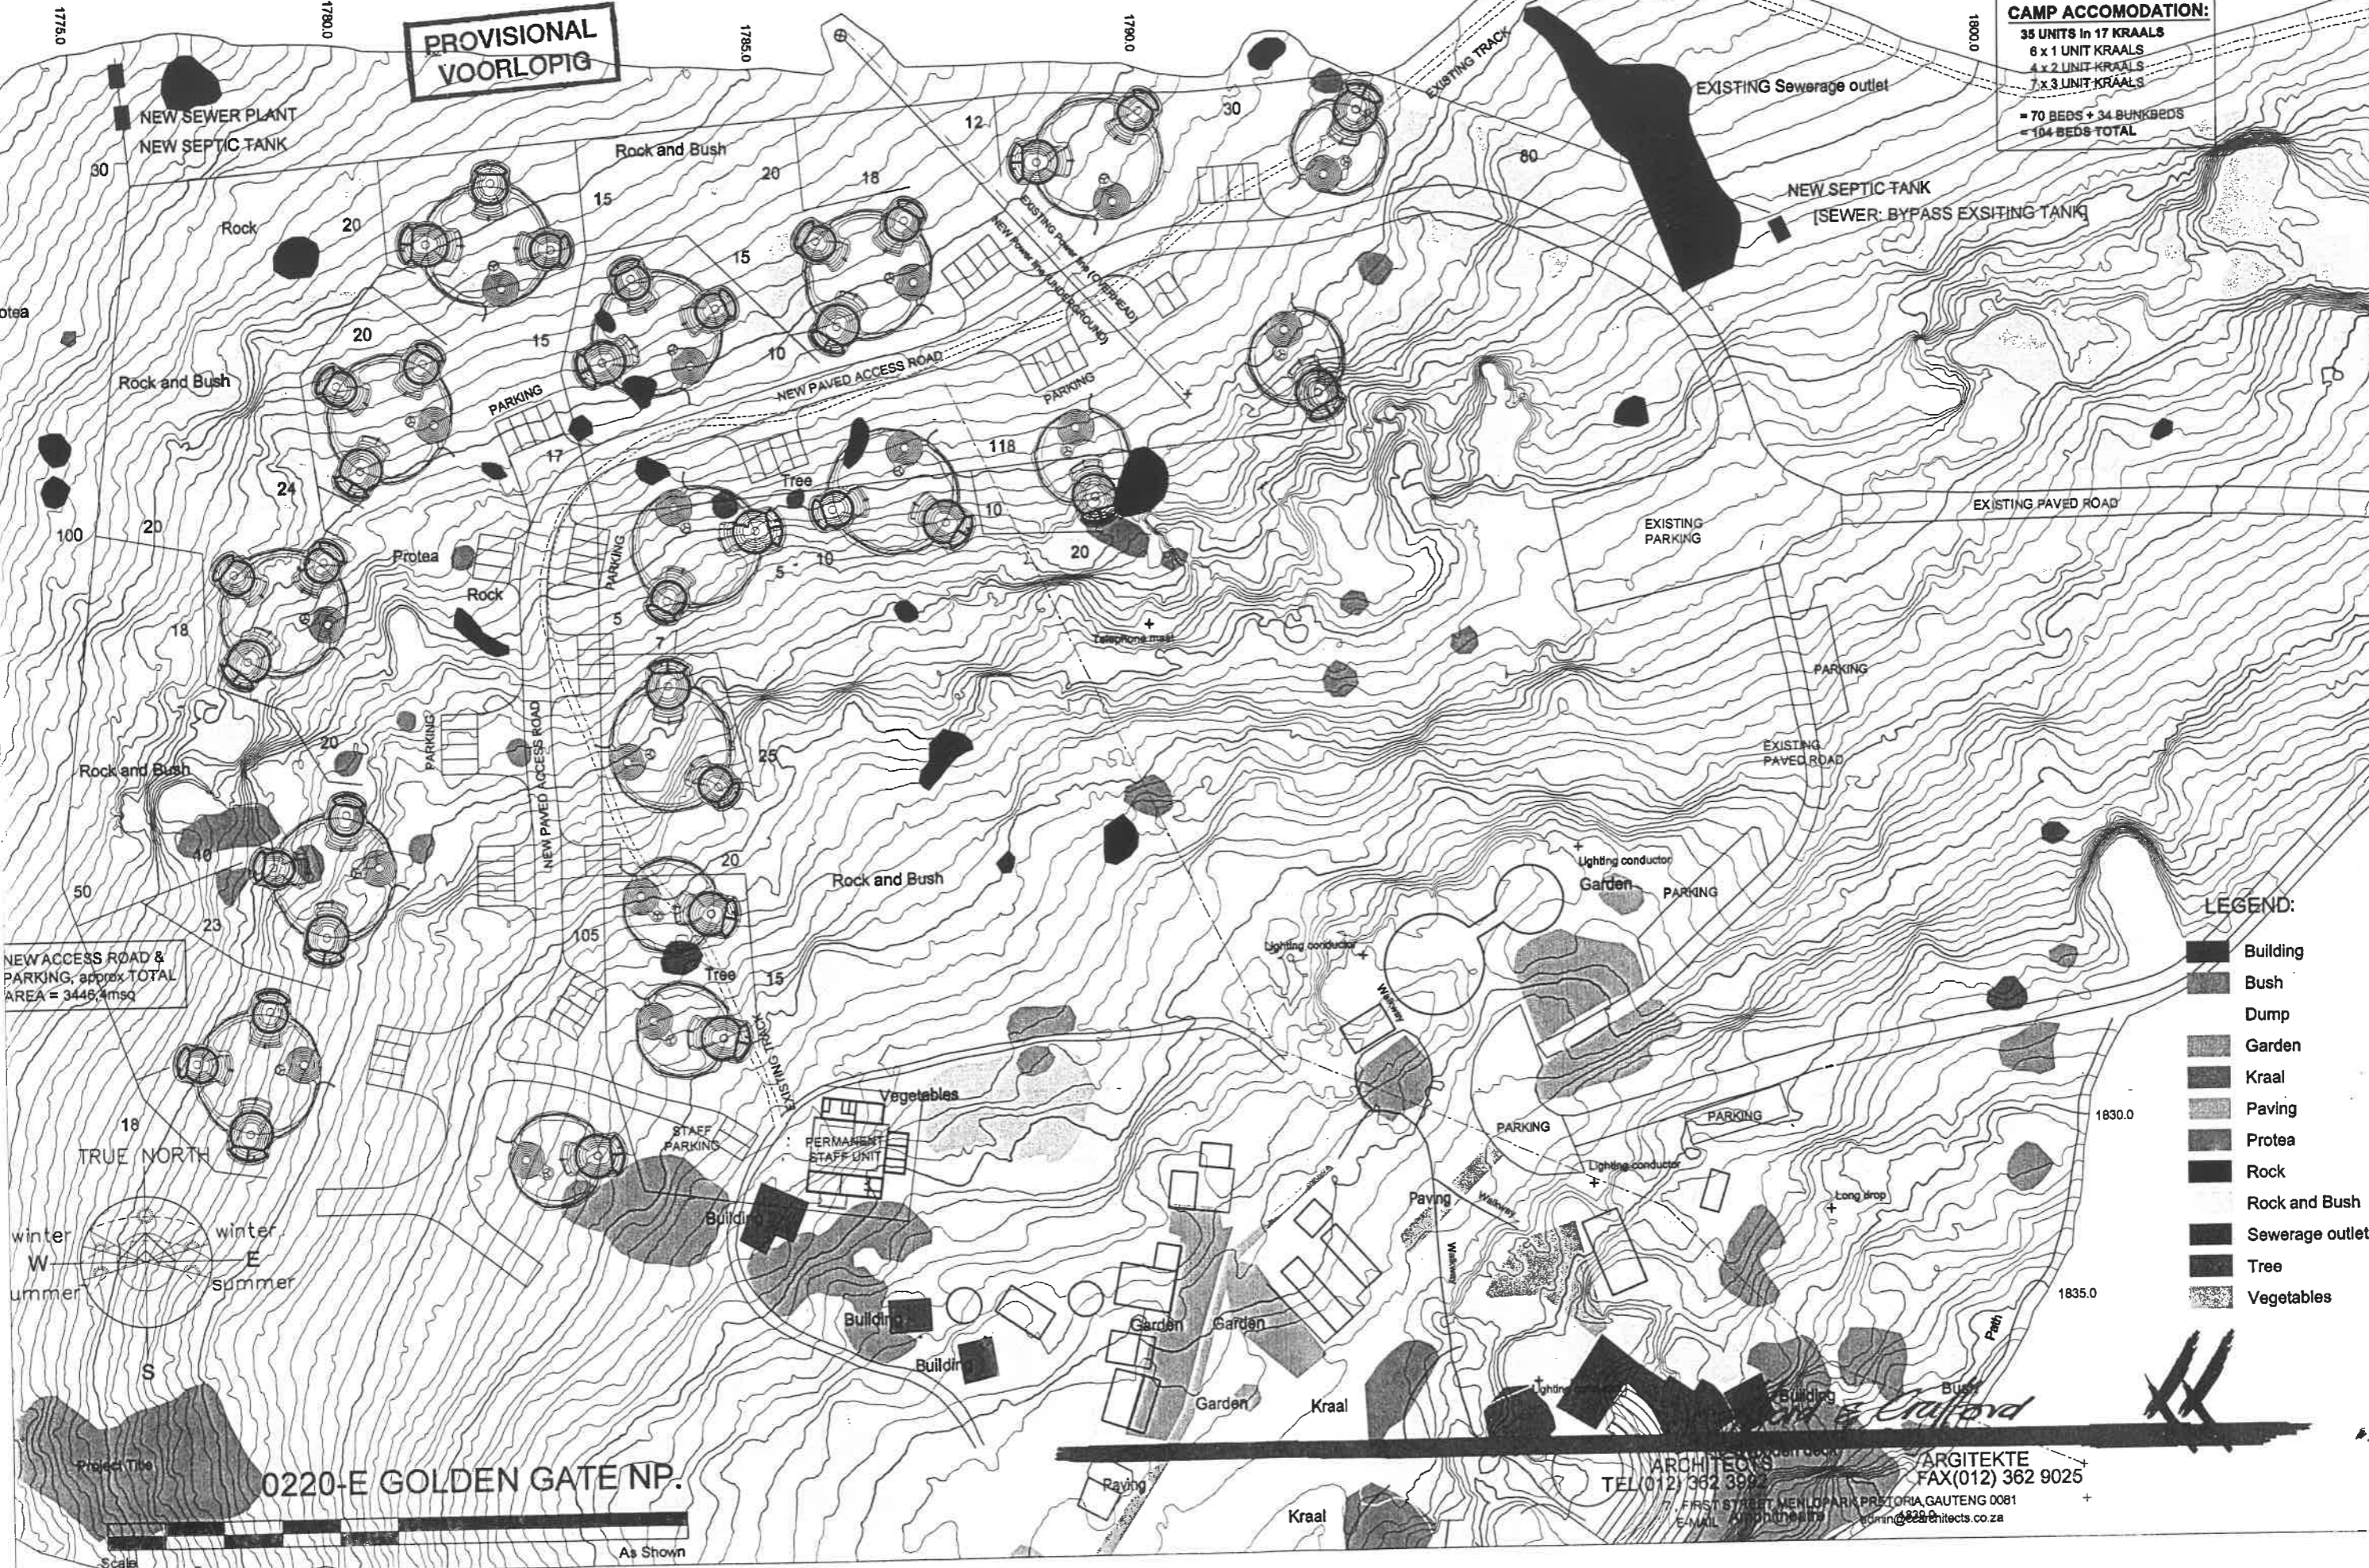

NEW ACCESS ROAD & PARKING, approx TOTAL AREA = 3446,4msq



Project Title **0220-E GOLDEN GATE NP.**

ARCHITECTS
TEL (012) 362 3992
FIRST STREET, MENLO PARK, PRETORIA, GAUTENG 0081
E-MAIL: info@crafford.co.za

ARGITEKTE
FAX (012) 362 9025
info@crafford.co.za



ALL LOCAL & NATIONAL BUILDING REGULATIONS MUST BE COMPLIED WITH. ALL DIMENSIONS TO BE CHECKED ON SITE.
THIS DRAWING TO BE USED ONLY ON ORIGINAL DESIGNATED SITE UNLESS OTHERWISE AGREED BY ARCHITECTS.
Copyright Reserved Crafford & Crafford Architects © 2002

Drawing Title **QWAQWA SITE: ELECTRICAL LAYOUT**

Tekening Naam 1795.0

| | | | |
|----------------|------------------------|--------|-----------|
| Drawn PN | Geteken Project 0220-E | Projek | TEK # DWG |
| Scale 1 : 1000 | Skaal Date 20.10.2003 | Datum | 102704 |

**PROVISIONAL
VOORLOPIG**

CAMP ACCOMODATION:
35 UNITS in 17 KRAALS
6 x 1 UNIT KRAALS
4 x 2 UNIT KRAALS
7 x 3 UNIT KRAALS
= 70 BEDS + 34 BUNKBEDS
= 104 BEDS TOTAL

REVISION WYSIGING



NEW ACCESS ROAD & PARKING: approx TOTAL AREA = 3448.4msq



0220-E GOLDEN GATE NP.

ARCHITECTS
TEL (012) 362 3992
FIRST STREET, MENLO PARK, PRETORIA, GAUTENG 0081
E-MAIL: crafford@architects.co.za

ARGITEKTE
FAX (012) 362 9025

