



**1 Floor Plan**

1 : 50

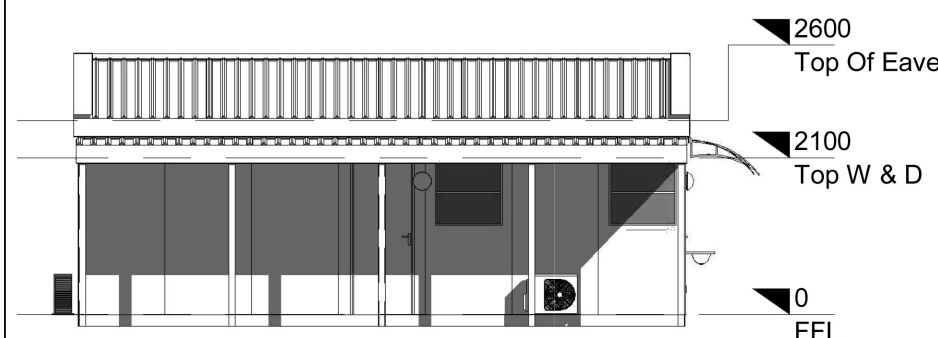

**2 South Elevation**

1 : 100

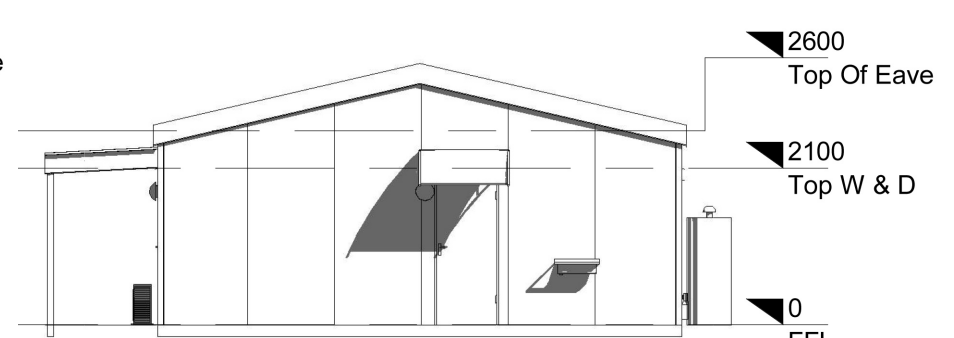

**3 East Elevation**

1 : 100

Floor Schedule		
Type Mark	Description	Area
SF	Suspended Floor	57 m <sup>2</sup>
VT	Vinyl Floor Tile	56 m <sup>2</sup>

Door Schedule		
Item Code	Description	Count
DE4LH	Single Panel Door External 40mm Left Hand with Flyscreen	1
DE4RH	Single Panel Door External 40mm Right Hand with Flyscreen	1
DI4LH	Single Panel Door Internal 40mm Left Hand with Flyscreen	2
DI4RH	Single Panel Door Internal 40mm Right Hand with Flyscreen	1

Lighting Fixture Schedule			
Image	Item Code	Description	Count
	Ex W/L	External Wall Bulk Light	2
	F/L	Flourescent Double Light 1200mm	5
	JD90	Bulk light	1


Electrical Fixture Schedule			
Image	Item Code	Description	Count
		Double plug 16amp	8
		Stove Isolator	1
	1W	Light switch, 16amp, 4x2, 1 lever	5
	D/N	Day Night Switch	1
	DB	Distribution Board	1
	WE	Wall Mounted Extractor Fan	1

Window Schedule				
Item Code	Description	Count	Blinds	Flyscreens
A	Windows - 500x600mm Top Hung Alu Window, Obscure Glass with Flyscreen	1	No	Yes
B	900x900mm Top Hung Aluminium Window with flyscreen	5	Yes	Yes

Plumbing Fixture Schedule		
Item Code	Description	Count
	Double Sink	1
	Wash Trough	1
150L	150L Geyser	1
SH	900mm x 900mm Shower Tray	1
WC	Water Closet	1
WHB	Wash Hand Basin	1

Mechanical Equipment Schedule		
Item Code	Description	Count
9BTU	9000 BTU Split Unit	2
18BTU	18000 BTU Split Unit	1

No.	Date	Revision	Initial

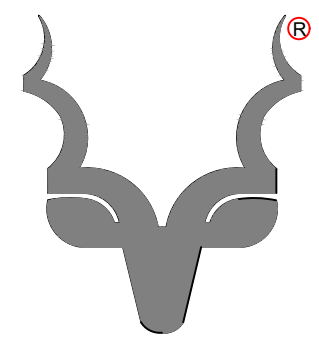

**South African NATIONAL PARKS**  
TECHNICAL SERVICES

Project \_\_\_\_\_

**GENERIC DRAWING  
2 BEDROOM PREFAB HOUSE**

Client \_\_\_\_\_

**MARAKELE NATIONAL PARK**

Drawing \_\_\_\_\_

**GENERIC LAYOUT**

**FOR PLANNING PURPOSES ONLY**

Scale 1: 50 (A3) Drawn B Jacobus

Checked \_\_\_\_\_ Date 07/04/2026

Signed \_\_\_\_\_ Date \_\_\_\_\_

Drawing No. \_\_\_\_\_ Rev. 00

This drawing and design is copyright and must not be reproduced in part or in whole without prior written consent. Contractors must verify all dimensions on site before commencing work or preparing shop drawings.